



TS-SCON - VISTA EXTERIOR

ESCALA 1:3

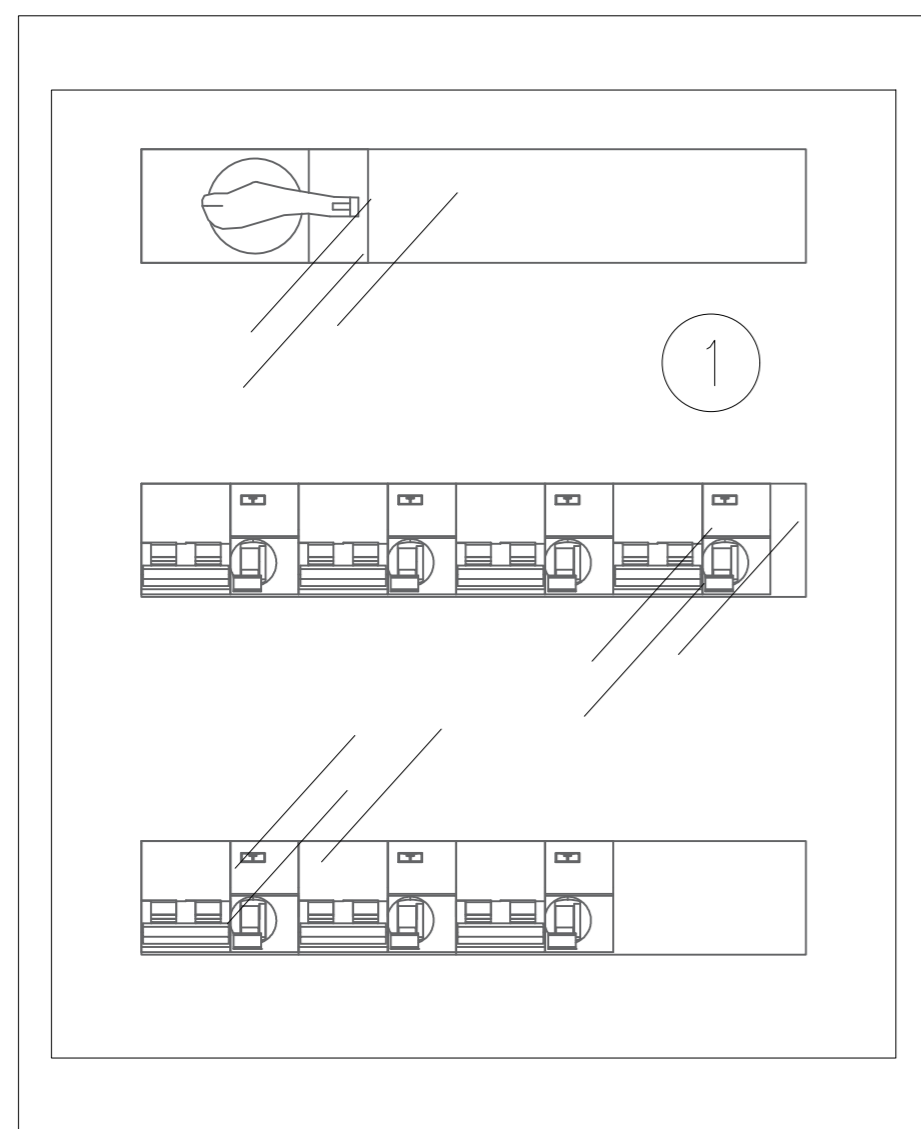

TS-SCON - VISTA INTERNA

ESCALA 1:3

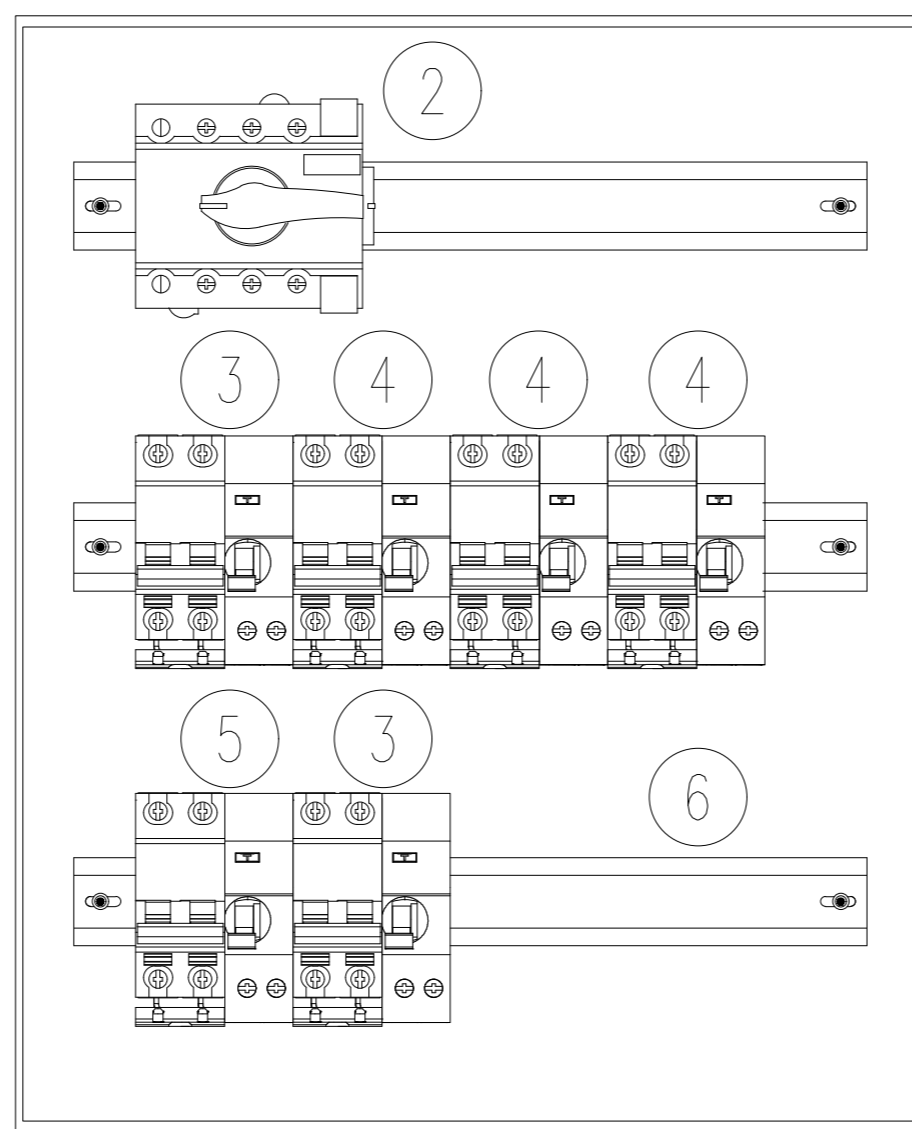


LISTADO DE MATERIALES:

ITEM	DESCRIPCIÓN
1	ARMARIO DE SOBREPONER, 48 MODULOS DIN, LINEA Q ENERGY. 0480548. SISTELECTRIC.
2	INTERRUPTOR SECCIONADOR INTERPACT INS40 4P 40A. SCHNEIDER.
3	INTERRUPTOR AUTOMATICO IC60N, CURVA C, 2 POLOS, 6A MAS VIGI 25A, 30mA. SCHNEIDER.
4	INTERRUPTOR AUTOMATICO IC60N, CURVA C, 2 POLOS, 16A MAS VIGI 25A, 30mA. SCHNEIDER.
5	INTERRUPTOR AUTOMATICO IC60N, CURVA C, 2 POLOS, 32A MAS VIGI 40A, 30mA. SCHNEIDER.
6	RIEL DE MONTAJE DIN, SIMÉTRICO SIN PERFORAR, L= 1000mm. MODELO NS-35. COD.: 800.003. MARCA: ZOLODA.

TGBT - UNIFILAR

ESCALA S:E

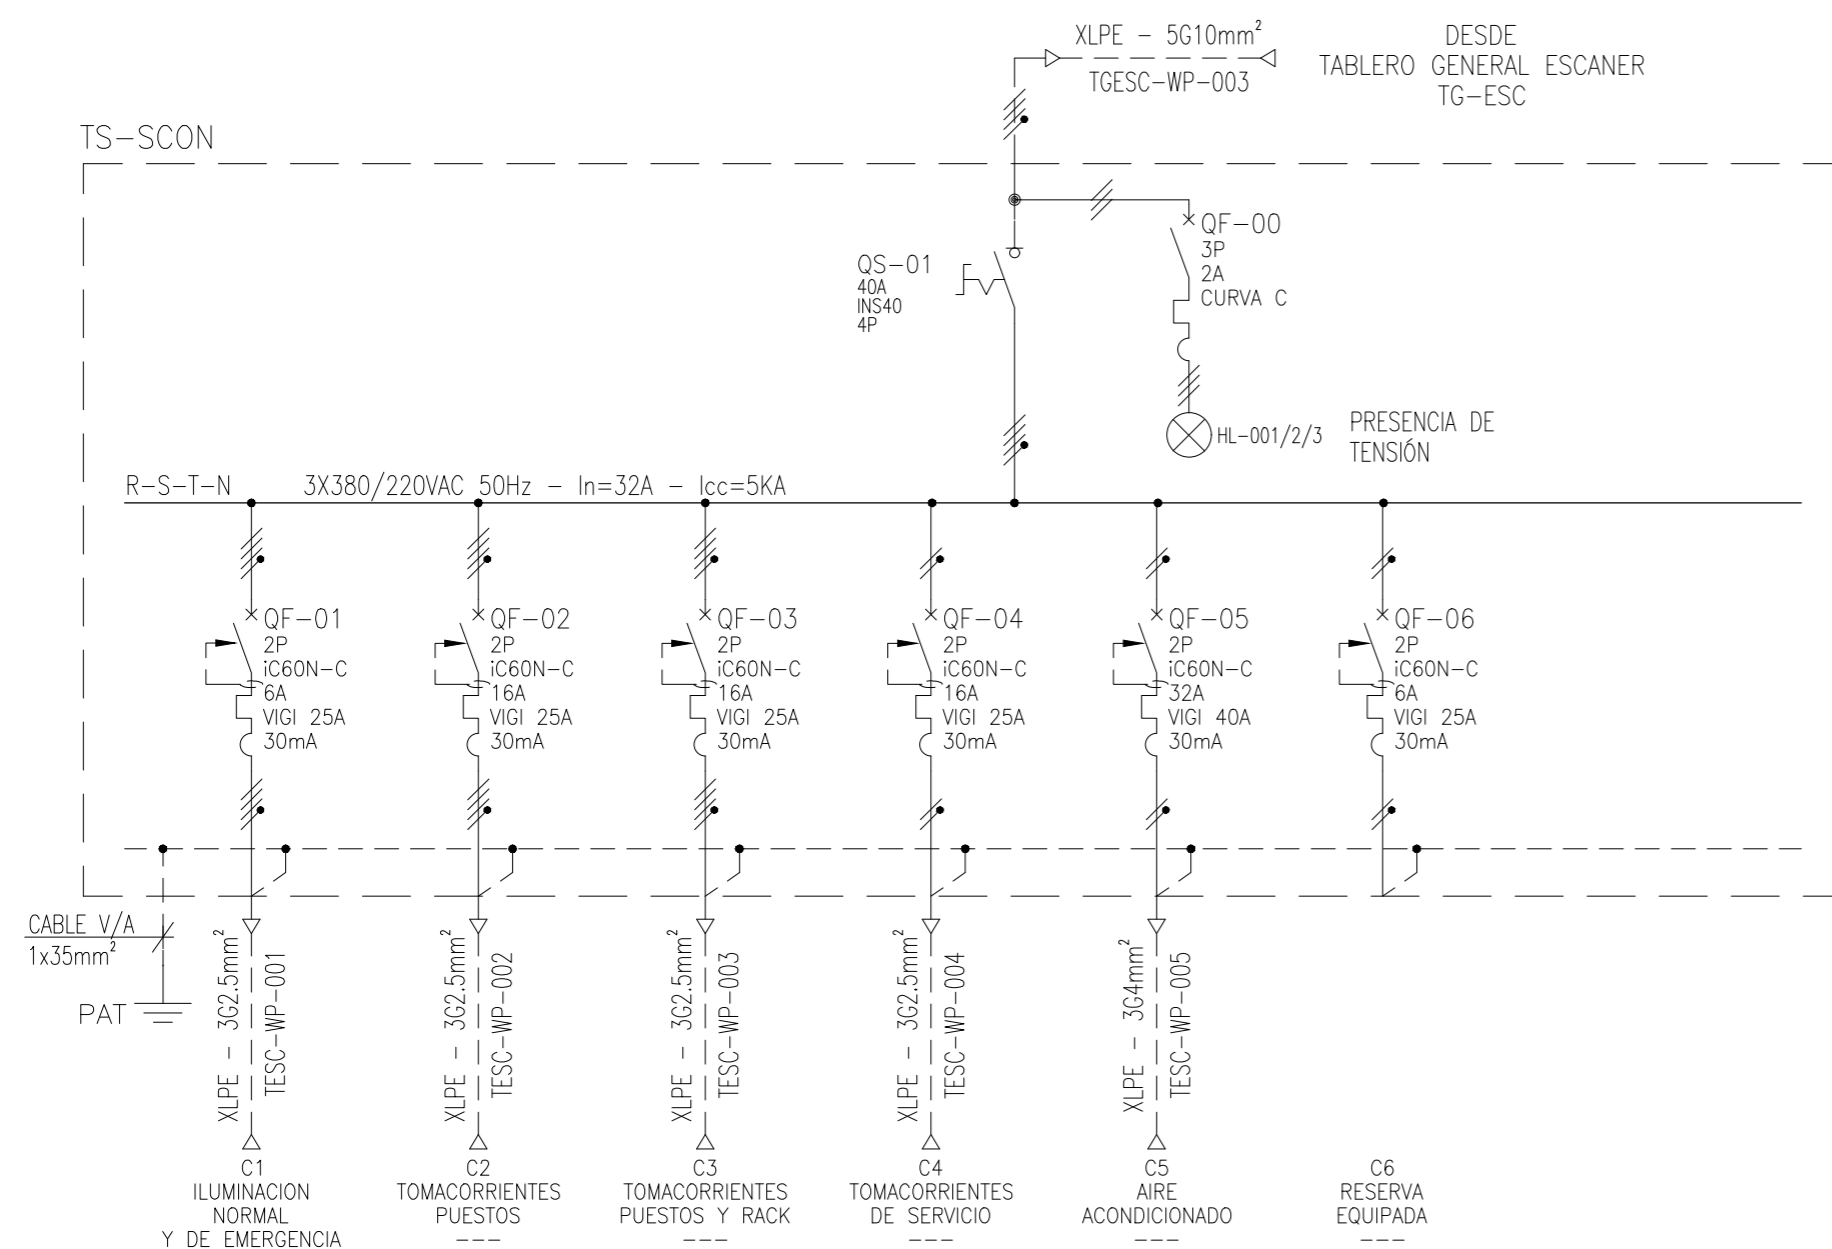

PLANO:

TABLERO TS-SCON - ESCANER MAS

<p>ADMINISTRACIÓN PORTUARIA <b>PUERTO MADRYN</b></p>	ESCALA: 1:100 / 1:10	Nº	20
	Dibujó: 25/02/2025	NOMBRE Ing. Maximiliano SANABRIA	
	Revisó: Aprobó: 27/02/2025	Lic. Marcelo MARCORA Ing. Mariano TAYLOR	